



LIGHT & VENTILATION SCHEDULE (SF)			
ROOM	AREA	LIGHT SUPPLIED	VENT SUPPLIED
FAMILY ROOM	252	38.7	17.19
DINING ROOM	204	25.8	11.46
KIT/NOOK	486	107.8	48.98
STUDY	100	12.9	5.73

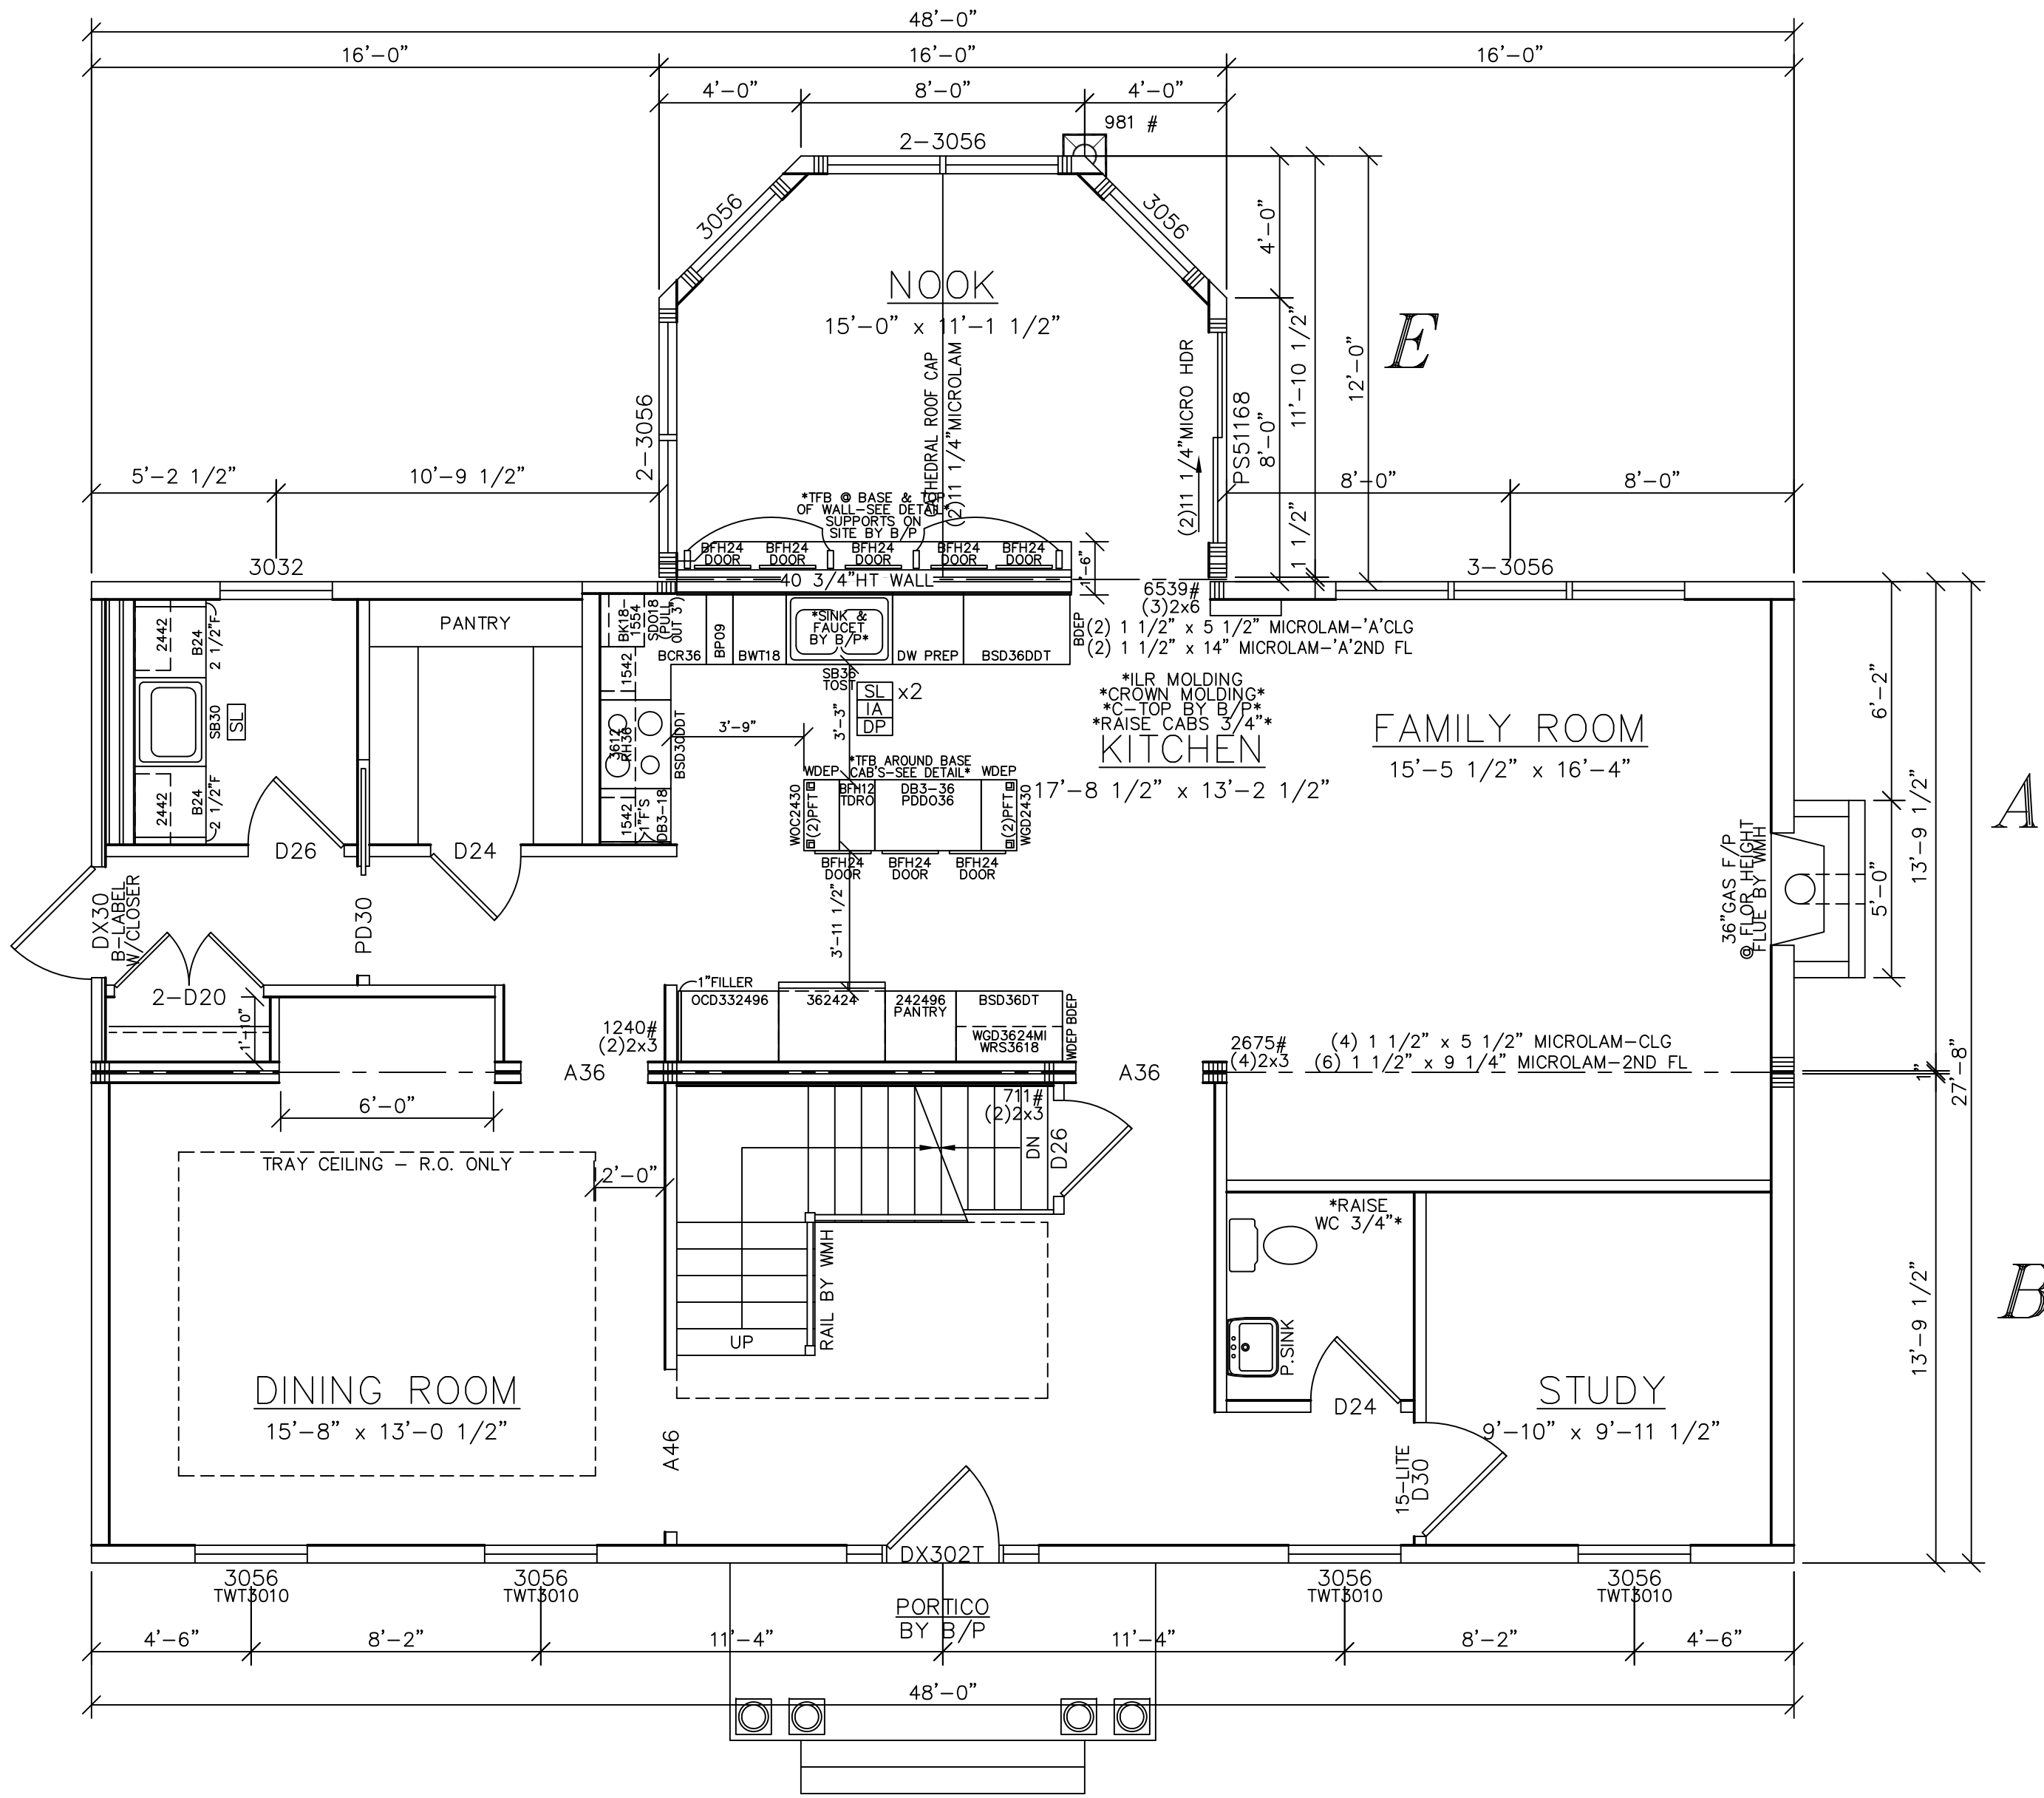

SEE STANDARD NOTES & DETAILS DWG #8

USE GROUP:	BUILDER:	HOMEOWNER:	THIRD PARTY INSPECTION AGENCY:
CONST. TYPE:	SITE:	PE / RA	
DESIGNER:	DATE:	SERIAL No.	
SCALE: 1/4" = 1'-0"	PAGE: 3A	PRODUCTION No.	
		REVISION	DATE
		CHECK	DATE
BOSTONIAN FIRST FLOOR PLAN		Westchester Modular Homes Inc 30 Reagans Mill Road, Wingdale, New York, 12594 Tel (845)832-9400 Fax (845)832-6698	

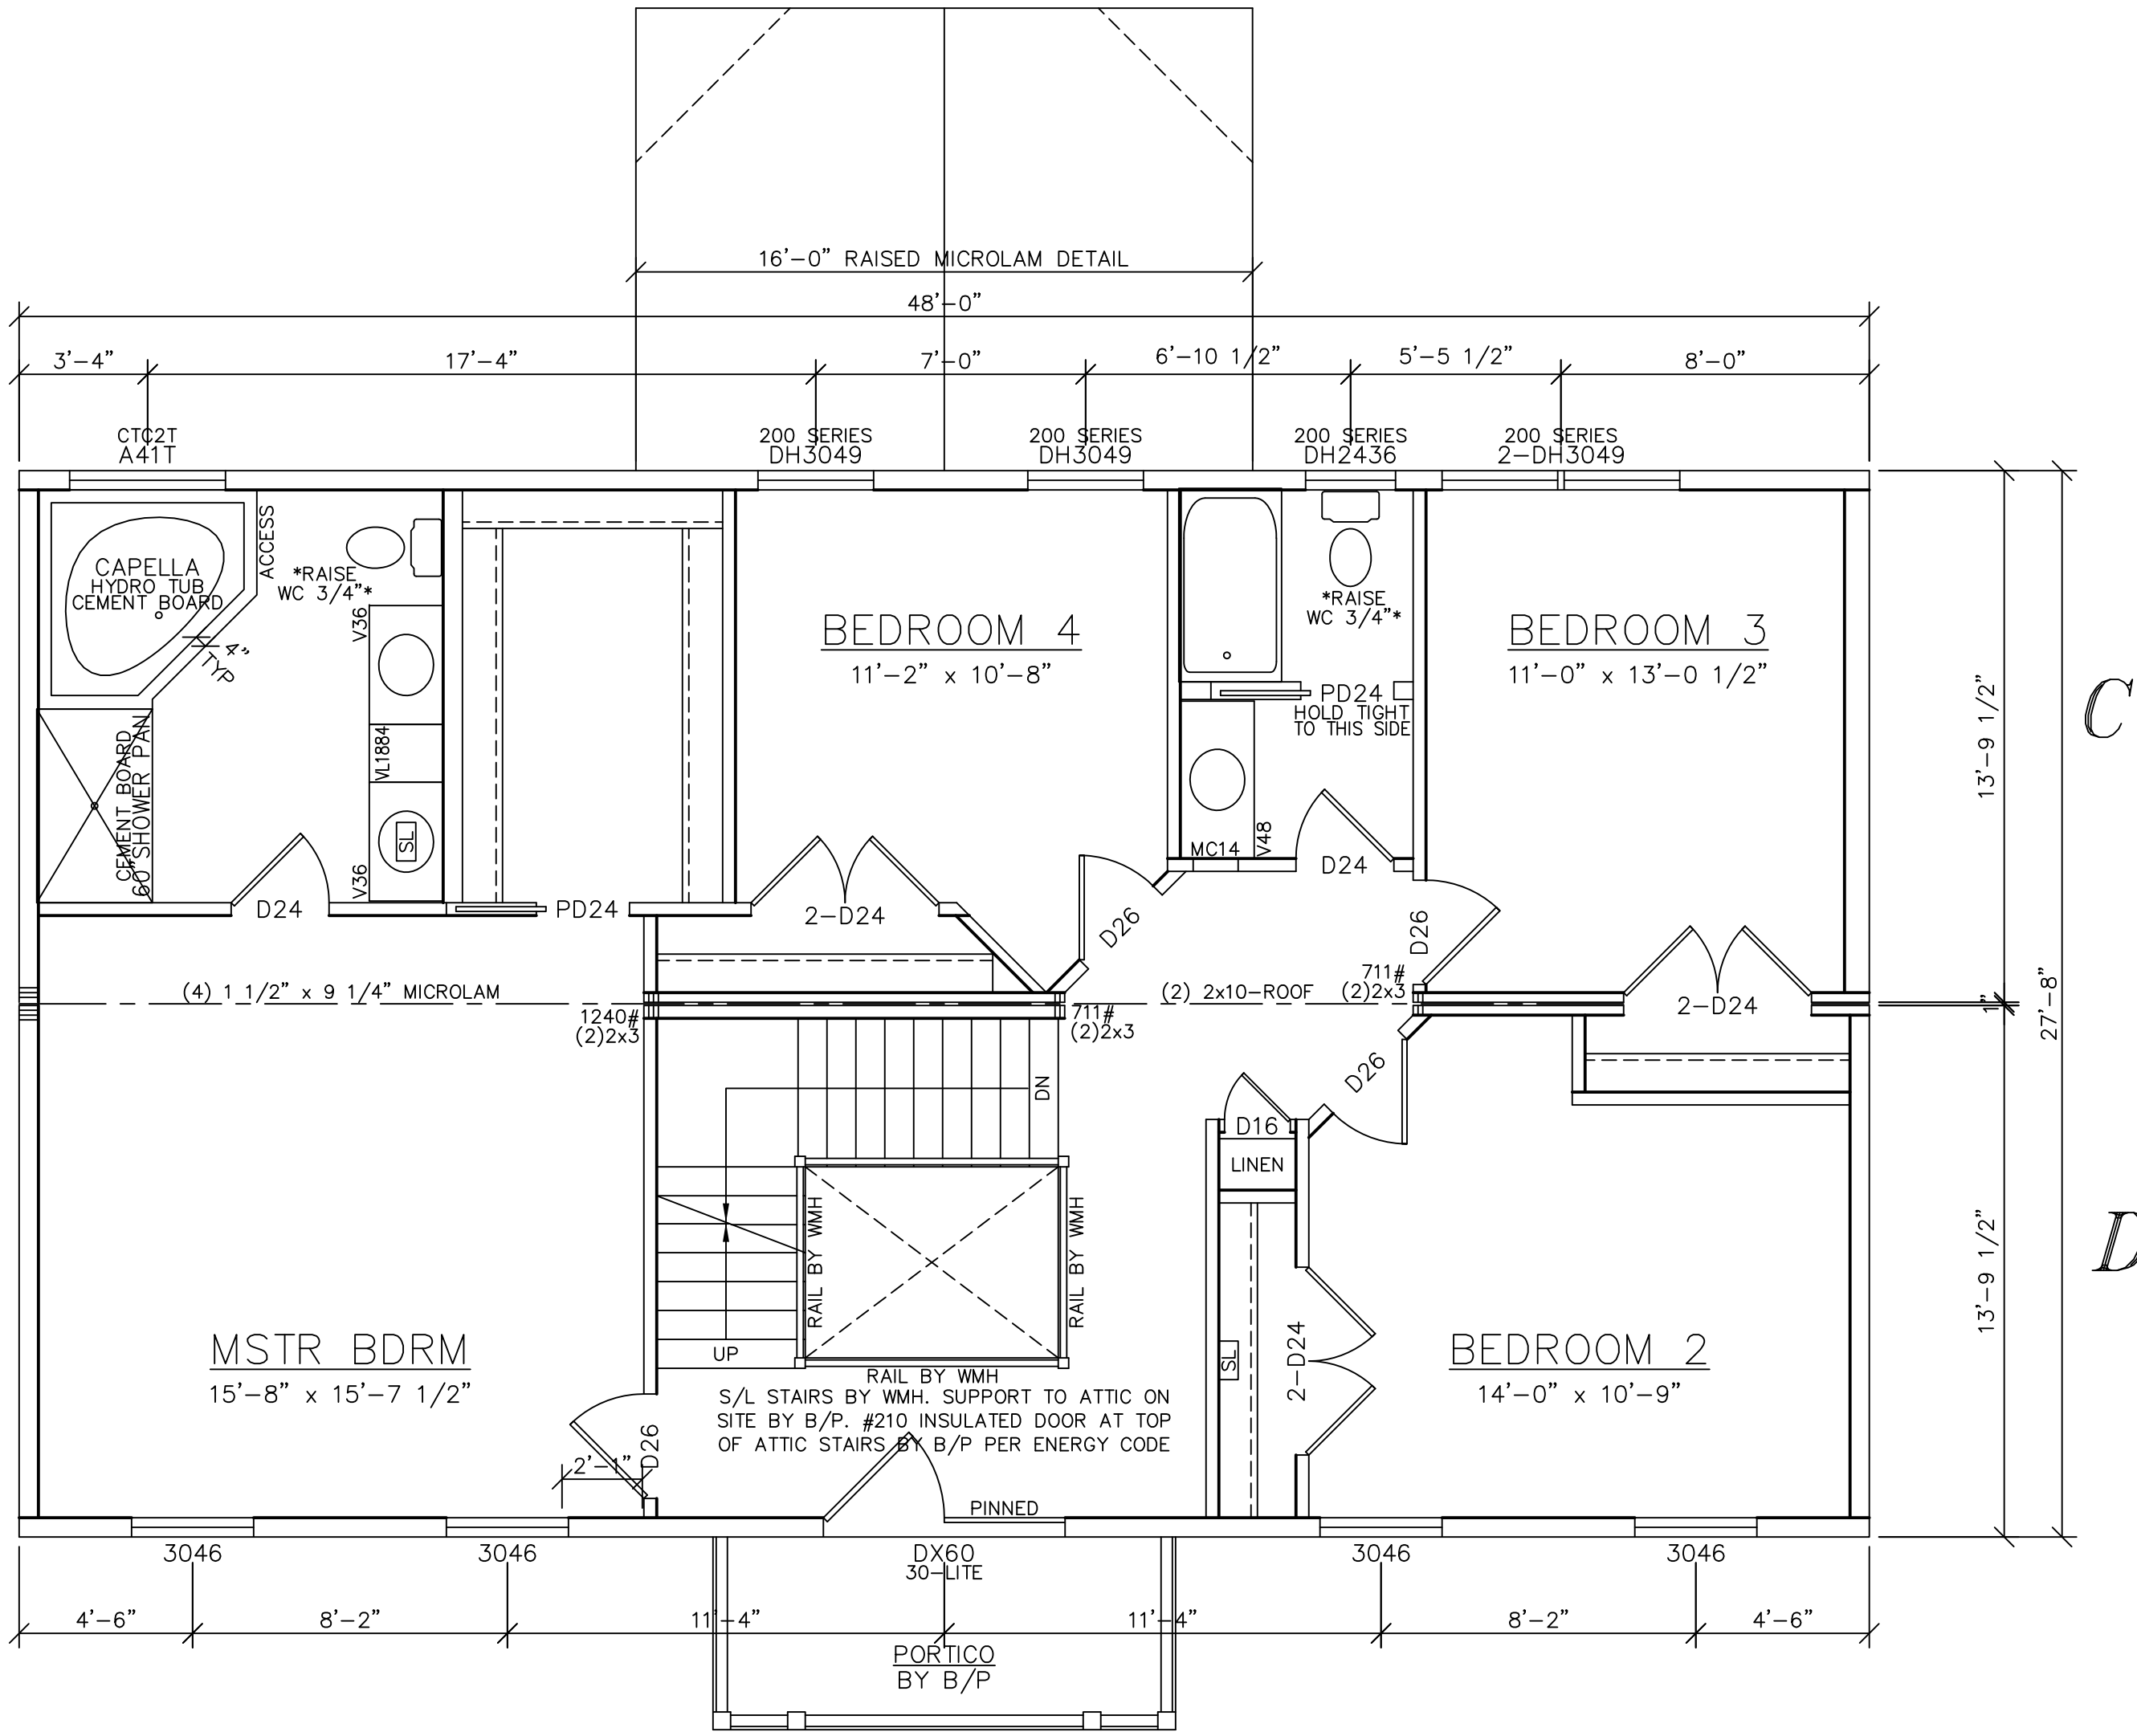

LIGHT & VENTILATION SCHEDULE (SF)

ROOM	AREA	LIGHT SUPPLIED	VENT SUPPLIED
MSTR BDRM	245	20.6	11.46
BEDROOM 2	151	20.6	11.46
BEDROOM 3	143	19.8	11.52
BEDROOM 4	119	19.8	11.52

SEE STANDARD NOTES & DETAILS DWG #8

USE GROUP:	BUILDER:	HOMEOWNER:	THIRD PARTY INSPECTION AGENCY:
CONSTR. TYPE:	SITE:	SERIAL No.	PE / RA
DESIGNER:	<p>BOSTONIAN SECOND FLOOR PLAN</p> <p>Westchester Modular Homes Inc 30 Reagans Mill Road, Wingdale, New York, 12594 Tel (845)832-9400 Fax (845)832-6698</p>	PRODUCTION No.	
DATE:		REVISION	DATE
SCALE: 1/4" = 1'-0"		CHECK	DATE
PAGE: 3B			