
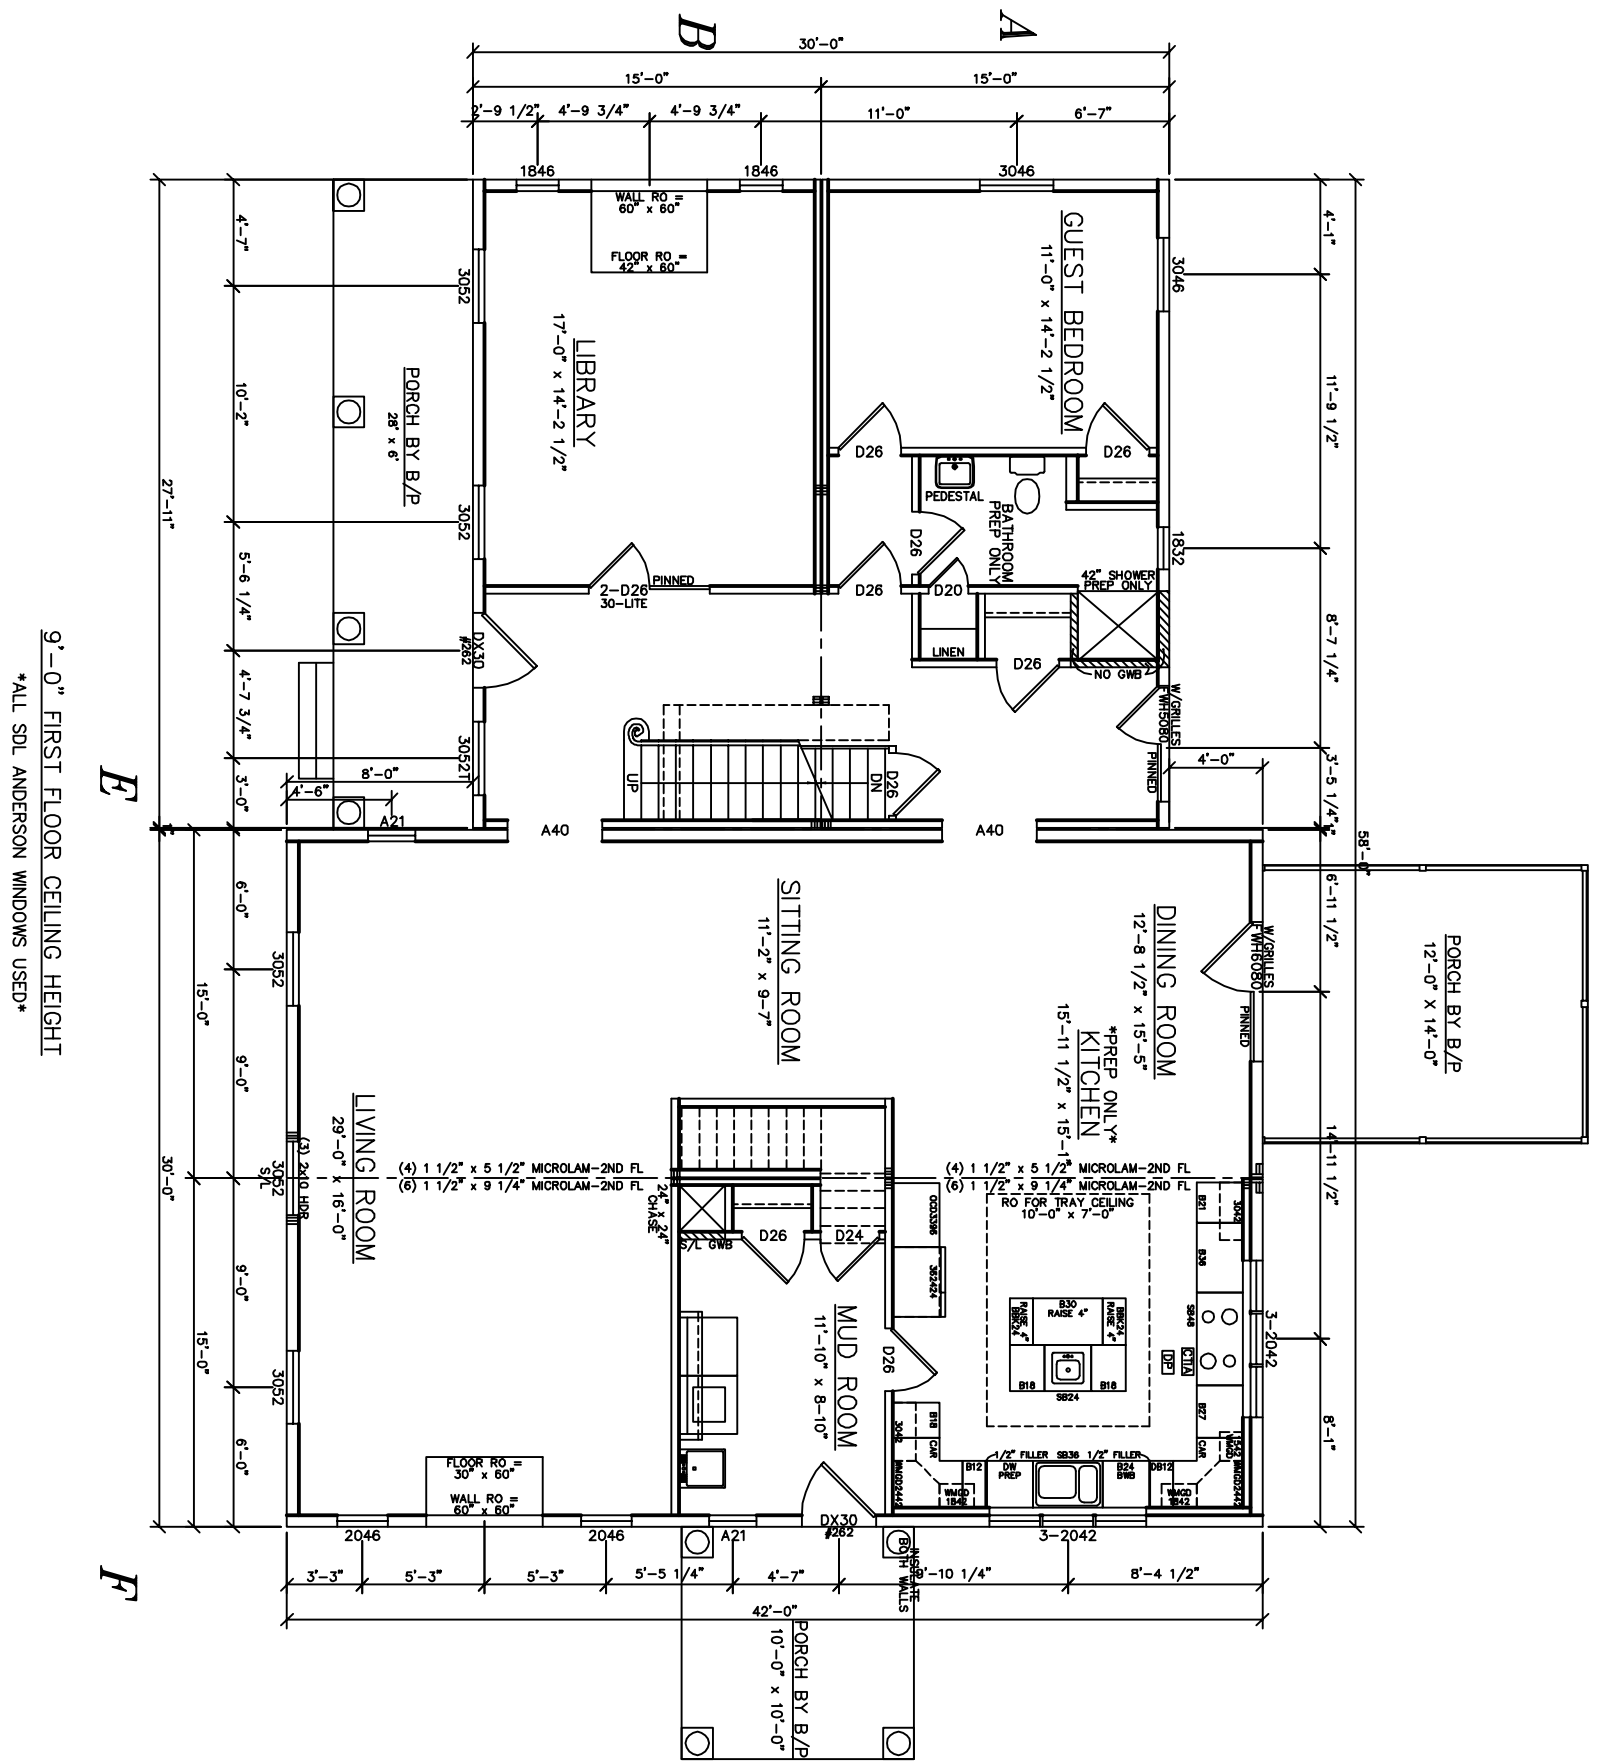


SEE STANDARD NOTES & DETAILS DWG #8

USE GROUP: <b>R4</b>	BUILDER:	HOMEOWNER:	SERIAL No. <b>03009</b>	PE / RA	THIRD PARTY INSPECTION AGENCY
CONST. TYPE: WOOD FRAME		SITE:	PRODUCTION No.		
DESIGNER: <b>M. GAMBY</b>	<b>COLONIAL CTM-R ELEVATIONS</b>			REVISION	DATE
DATE: 01-28-03				MG	03-21-03
SCALE: 1/8" = 1'-0"	 <b>Westchester Modular Homes Inc</b> 30 Reagans Mill Road, Wingdale, New York, 12594 Tel (914)832-9400 Fax (914)832-6698			CHECK	DATE
PAGE: <b>1</b>					

LIGHT & VENTILATION SCHEDULE (SF)			
ROOM	AREA	LIGHT SUPPLIED	VENT SUPPLIED
LIVING ROOM	464	51.2	28.21
DINING ROOM	196	27.4	40.71
KITCHEN	241	34.8	20.40
LIBRARY	242	33.8	19.38
GUEST BRDR	156	20.6	11.48




SEE STANDARD NOTES & DETAILS DWG #8

USE GROUP: <b>R4</b>	BUILDER:	HOMEOWNER:	SERIAL No. <b>03009</b>	PE / RA	THIRD PARTY INSPECTION AGENCY
CONST. TYPE: WOOD FRAME		SITE:	PRODUCTION No.		
DESIGNER: <b>M. GAMBY</b>	<b>COLONIAL CTM-R</b>			REVISION	DATE
DATE: 01-28-03				MG	03-21-03
SCALE: 3/16" = 1'-0"	<b>FIRST FLOOR PLAN</b>			MG	04-08-03
PAGE: <b>3A</b>					
	Westchester Modular Homes Inc 30 Reagans Mill Road, Wingdale, New York, 12594 Tel (914)832-9400 Fax (914)832-6698			CHECK	DATE

LIGHT & VENTILATION SCHEDULE (SF)			
ROOM	AREA	LIGHT SUPPLIED	VENT SUPPLIED
MSTR BDRM	464	51.2	28.21
BEDROOM 2	289	30.4	17.50
BEDROOM 3	219	20.6	11.46

\*ALL SPL ANDERSON WINDOWS\*

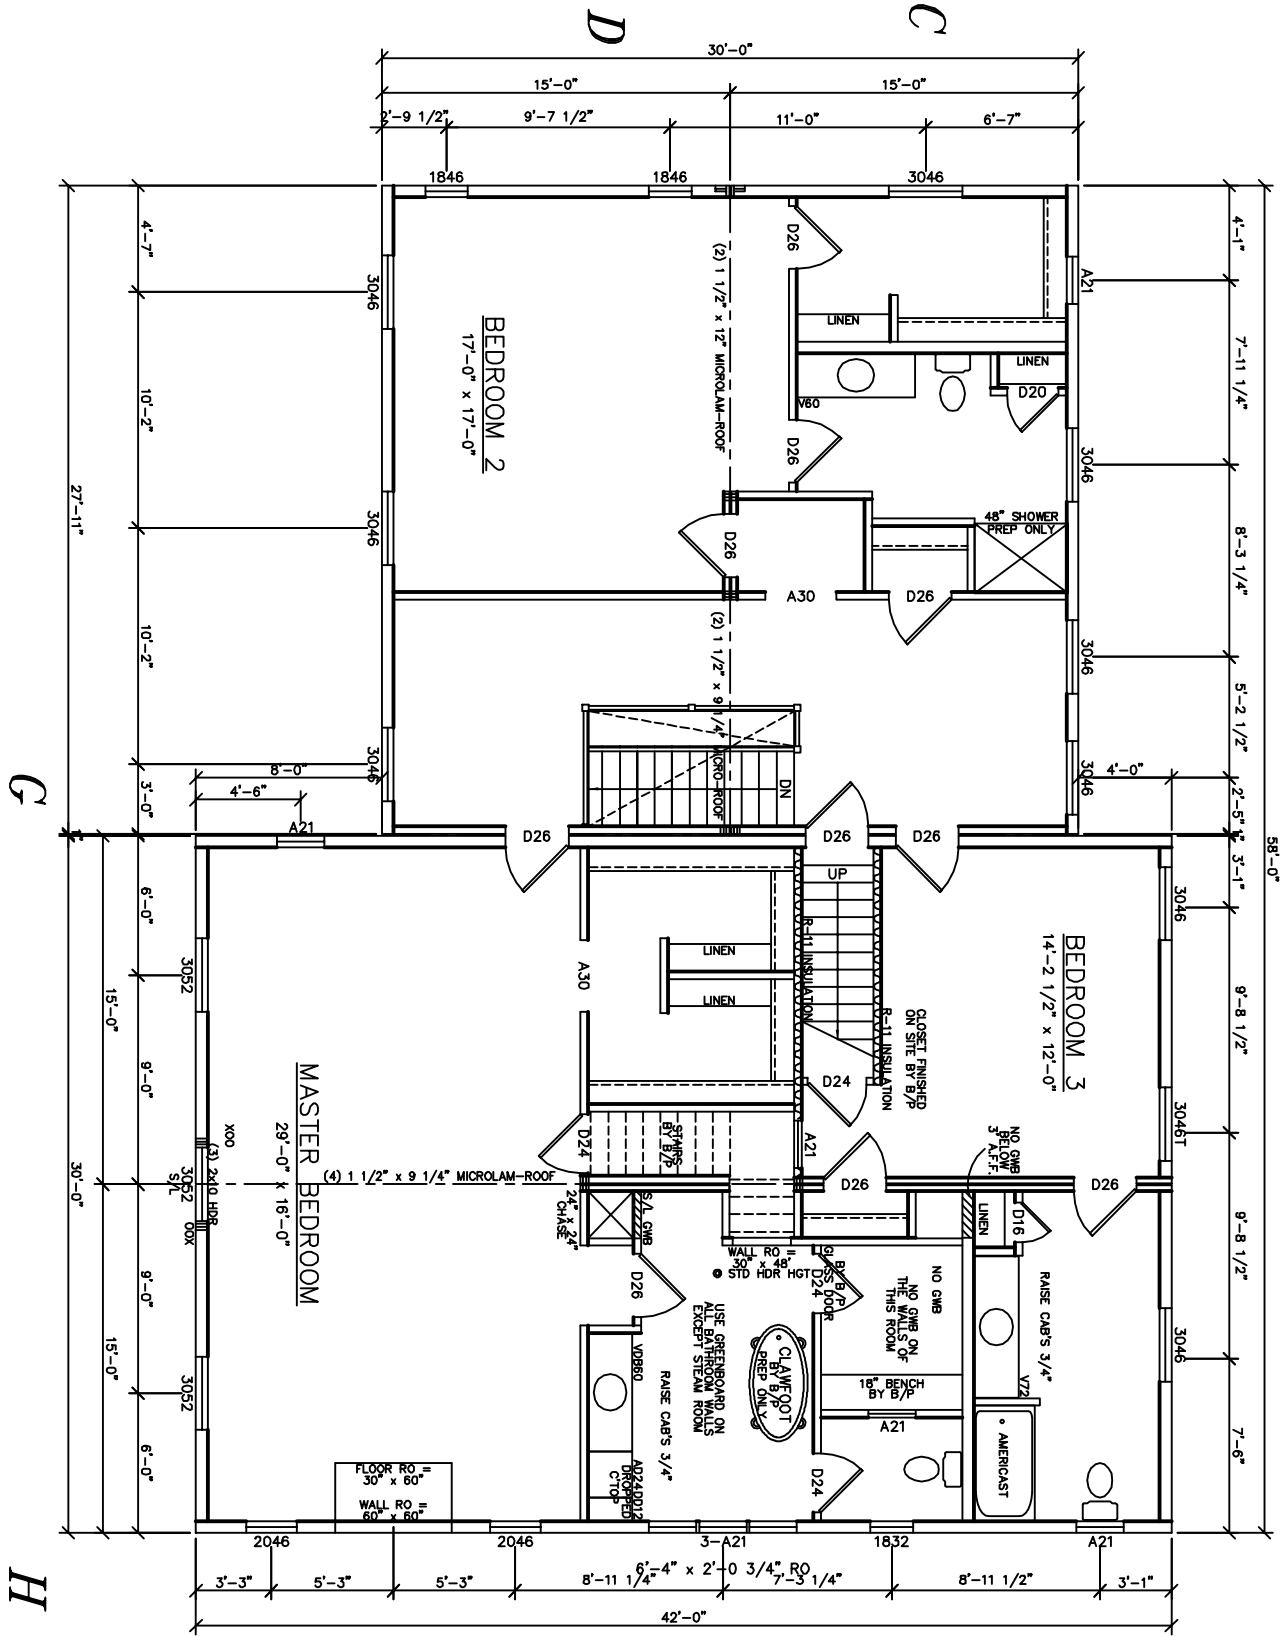

SEE STANDARD NOTES & DETAILS DWG #8

USE GROUP: <b>R4</b>	BUILDER:	HOMEOWNER:	SERIAL No. <b>03009</b>	PE / RA	THIRD PARTY INSPECTION AGENCY
CONST. TYPE: WOOD FRAME		SITE:	PRODUCTION No.		
DESIGNER: <b>M. GAMBY</b>	<b>COLONIAL CTM-R</b> <b>SECOND FLOOR PLAN</b>		REVISION	DATE	
DATE: 01-28-03			MG	03-21-03	
SCALE: 3/16" = 1'-0"			MG	04-08-03	
PAGE: <b>3B</b>			CHECK	DATE	
	Westchester Modular Homes Inc 30 Reagans Mill Road, Wingdale, New York, 12594 Tel (914)832-9400 Fax (914)832-6698				