


OVERHANG DIMENSION (*)			
ROOF PITCH	HOUSE WIDTH		
5/12	24'-0"	26'-0"/30'-0"	27'-8"/31'-8"
7/12	16"	11"	16"
9/12	12"	11"	12"
12/12	8 3/4"	8 3/4"	8 3/4"

NOTE:
WINDOW GRILLE PATTERNS SHOWN ARE FOR ANDERSEN WINDOWS.
GRILLE PATTERNS FOR OTHER MANUFACTURERS MAY BE DIFFERENT.

PE / RA

STATE AGENCY / THIRD PARTY INSPECTION AGENCY

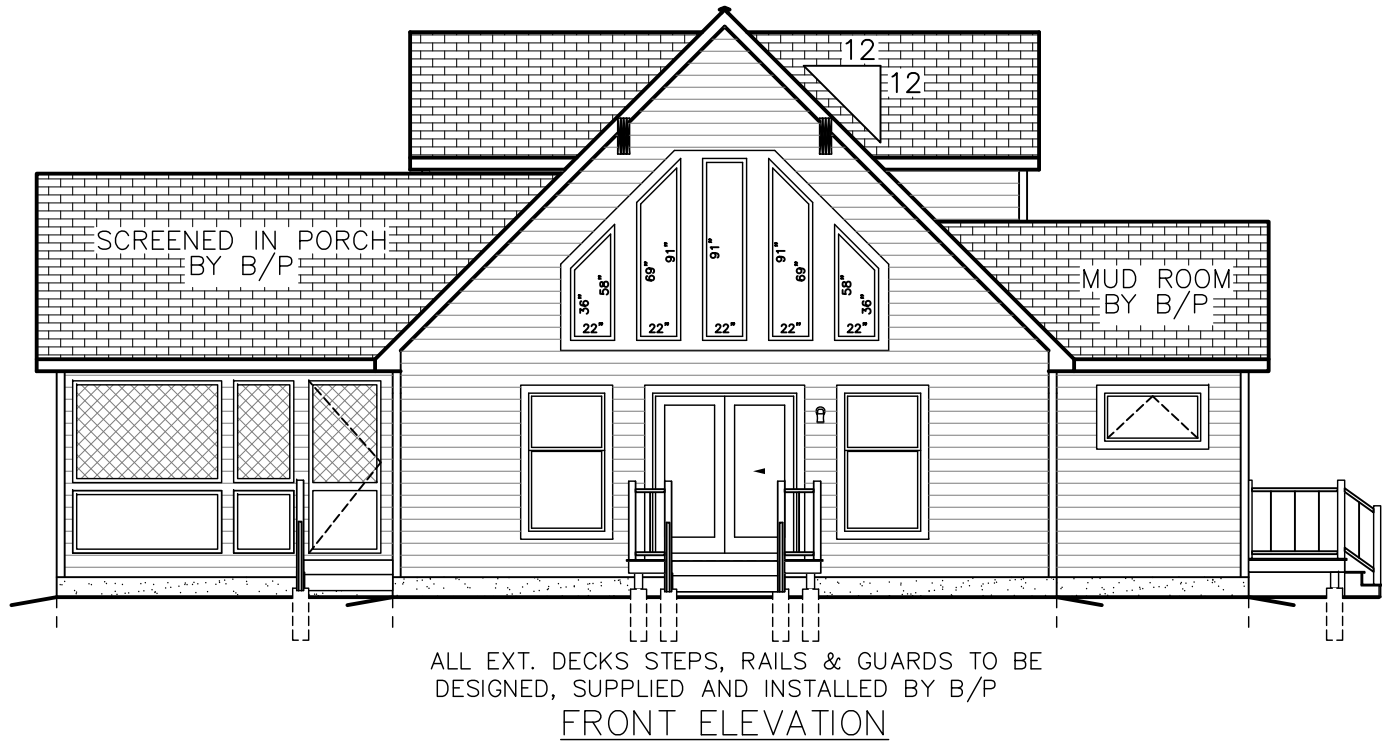


ALL EXT. DECKS STEPS, RAILS & GUARDS TO BE DESIGNED, SUPPLIED AND INSTALLED BY B/P

ALL WINDOW TRIM & SIDING BY B/P



SEE STANDARD NOTES & DETAILS DWG #8

USE GROUP: SINGLE FAMILY	BUILDER: ACO CONSTRUCTION LLC PO BOX 57 WILMINGTON, NY 12997	HOMEOWNER: SITE:	SERIAL No. 07175	PRODUCTION No. 5223	REVISION P.MCHUGH P.MCHUGH	DATE 8/28/07 10/1/07	CHECK	DATE
CONST. TYPE: 5B	DESIGNER: P.MCHUGH	DATE: 7/27/07	<h1>CHALET ELEVATIONS</h1>		CTM-R		Westchester Modular Homes Inc 30 Regans Mill Road, Wingdale, New York, 12594 Tel (914)832-9400 Fax (914)832-6698	
SCALE: 1/4" = 1'-0"	PAGE: 1							

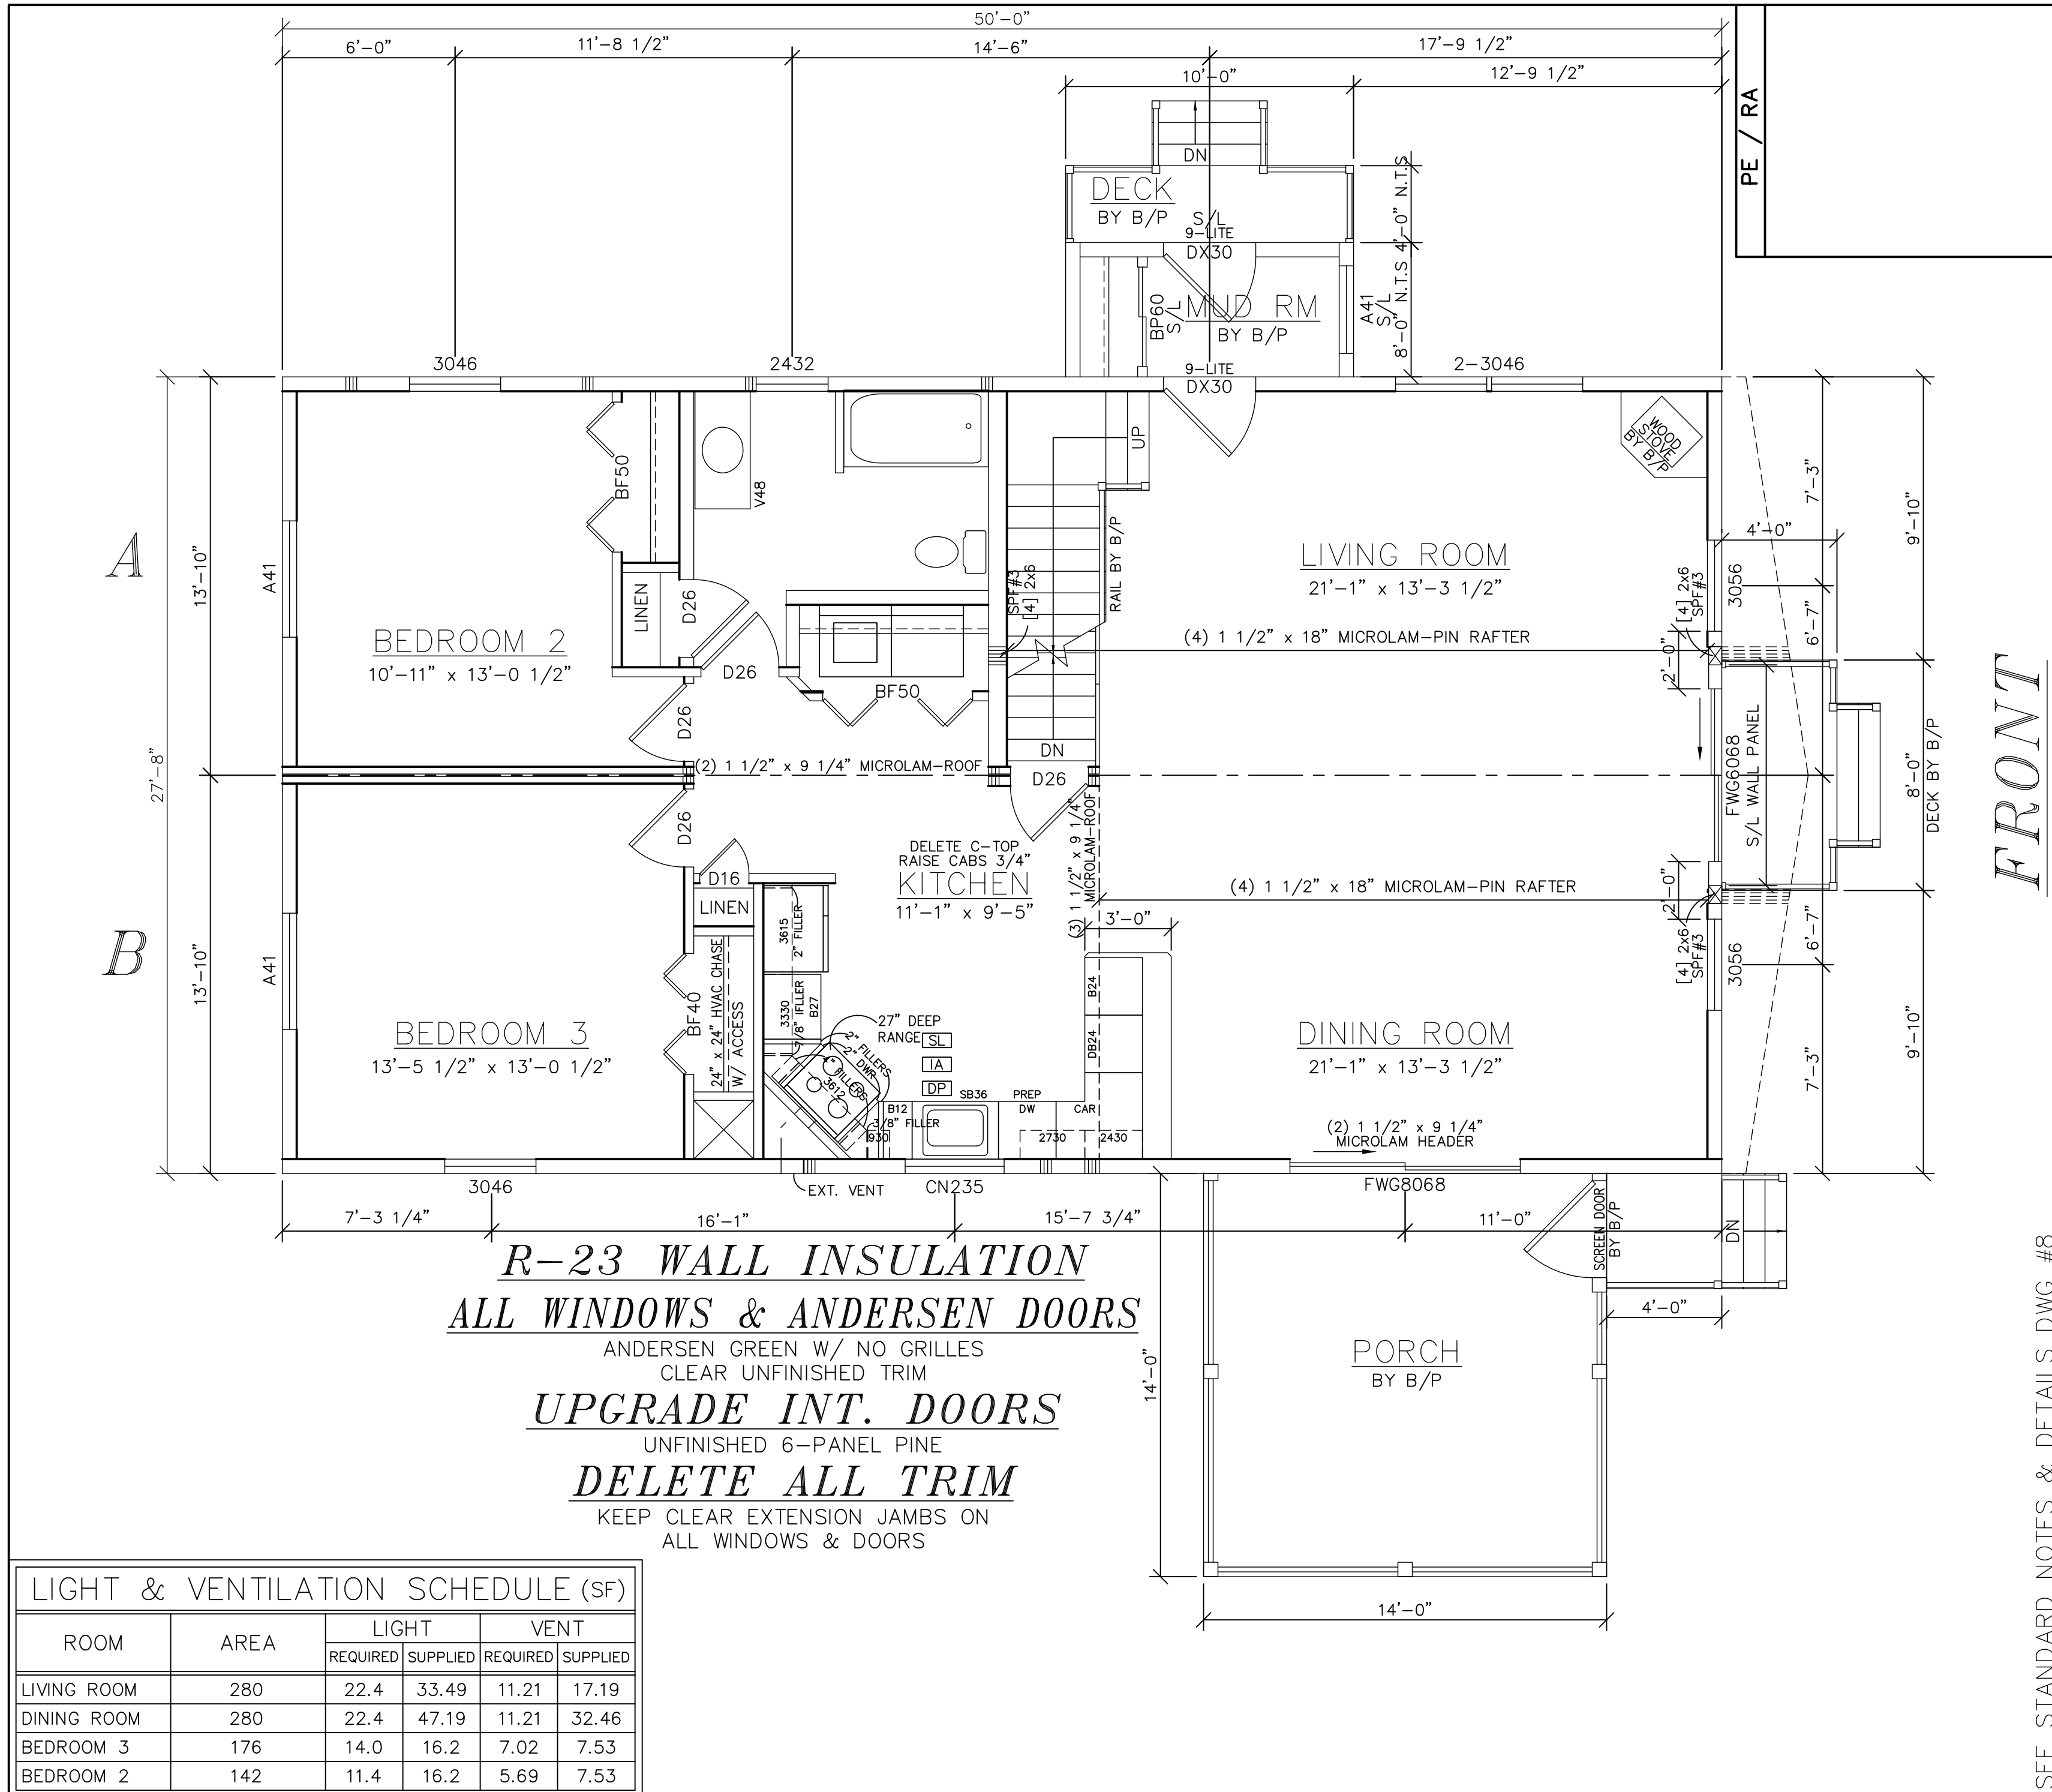

FRONT


SEE STANDARD NOTES & DETAILS DWG #8

STATE AGENCY / THIRD PARTY INSPECTION AGENCY		SERIAL No. 07175		REVISION DATE	
PRODUCTION No. 5223		P.MCHUGH 8/28/07		P.MCHUGH 10/1/07	
P.MCHUGH 10/16/07		CHECK DATE		DATE	
HOMEOWNER:		SITE:		DATE	
BUILDER:		ACONSTRUCTION LLC		WILMINGTON, NY 12997	
PO BOX 57		WILMINGTON, NY 12997		DATE	
DESIGNER:		DATE:		SCALE:	
P.MCHUGH		7/27/07		1/4" = 1'-0"	
PAGE:		PAGE:		PAGE:	
3A		3A		3A	

CHALET CTM-R
FIRST FLOOR PLAN

Westchester Modular Homes Inc
30 Regans Mill Road, Wingdale, New York, 12594
Tel (914)832-9400 Fax (914)832-6698

LIGHT & VENTILATION SCHEDULE (SF)					
ROOM	AREA	LIGHT		VENT	
		REQUIRED	SUPPLIED	REQUIRED	SUPPLIED
LIVING ROOM	280	22.4	33.49	11.21	17.19
DINING ROOM	280	22.4	47.19	11.21	32.46
BEDROOM 3	176	14.0	16.2	7.02	7.53
BEDROOM 2	142	11.4	16.2	5.69	7.53

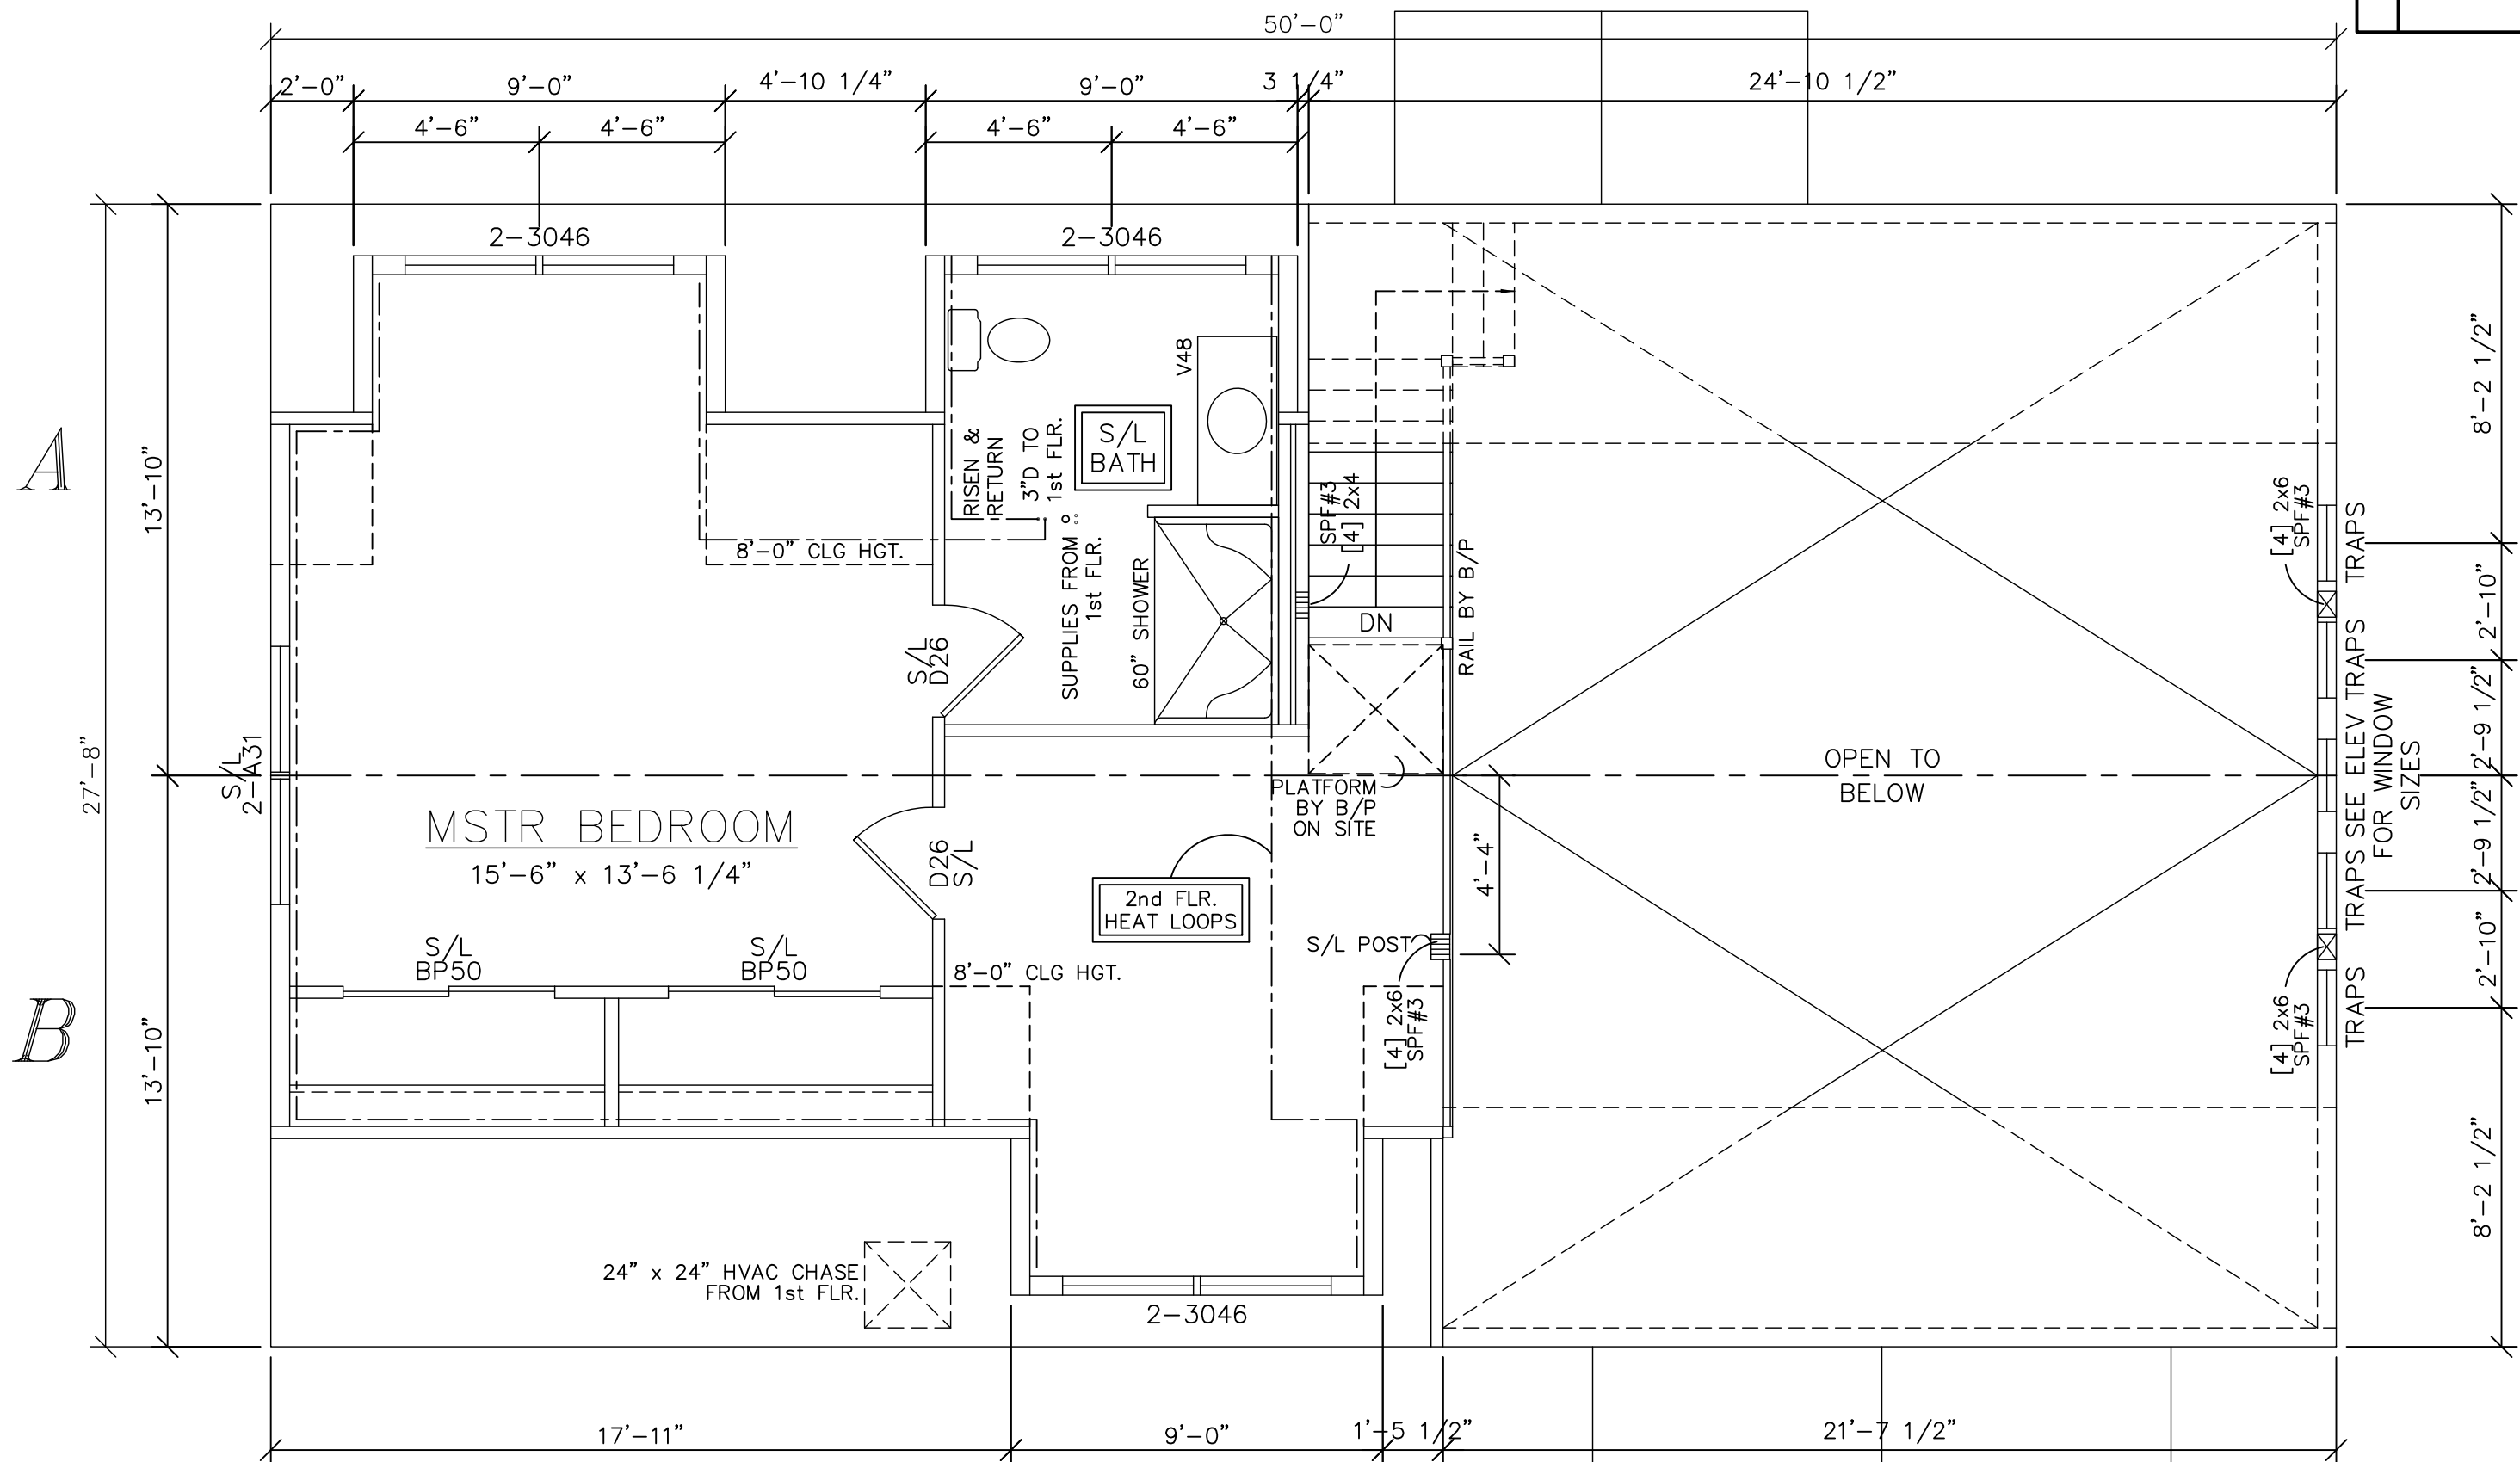

PE / RA

FRONT

R-23 WALL INSULATION
ALL WINDOWS & ANDERSEN DOORS

ANDERSEN GREEN W/ NO GRILLES
 CLEAR UNFINISHED TRIM

UPGRADE INT. DOORS

UNFINISHED 6-PANEL PINE

DELETE ALL TRIM

KEEP CLEAR EXTENSION JAMBS ON
 ALL WINDOWS & DOORS

All design and construction of 2nd floor is the on site responsibility of the builder and must be completed in accordance with local building code and inspection procedures. State approval of this project only pertains to the modular units as provided by Westchester Modular Homes Inc.

LIGHT & VENTILATION SCHEDULE (SF)

ROOM	AREA	LIGHT		VENT	
		REQUIRED	SUPPLIED	REQUIRED	SUPPLIED
MSTR BEDROOM	209	16.7	39.2	8.37	14.06

STATE AGENCY / THIRD PARTY INSPECTION AGENCY

SERIAL No. **07175**

PRODUCTION No. **5223**

REVISION	DATE
P.MCHUGH	8/28/07
P.MCHUGH	10/1/07
P.MCHUGH	10/16/07
CHECK	DATE

BUILDER: ACO CONSTRUCTION LLC
 PO BOX 57
 WILMINGTON, NY 12997

CHALET CTM-R
SECOND FLOOR PLAN

Westchester Modular Homes Inc
 30 Regans Mill Road, Wingdale, New York, 12594
 Tel (914)832-9400 Fax (914)832-6698

USE GROUP: SINGLE FAMILY
 CONST. TYPE: 5B
 DESIGNER: P.MCHUGH
 DATE: 7/27/07
 SCALE: 1/4" = 1'-0"
 PAGE: 3B