
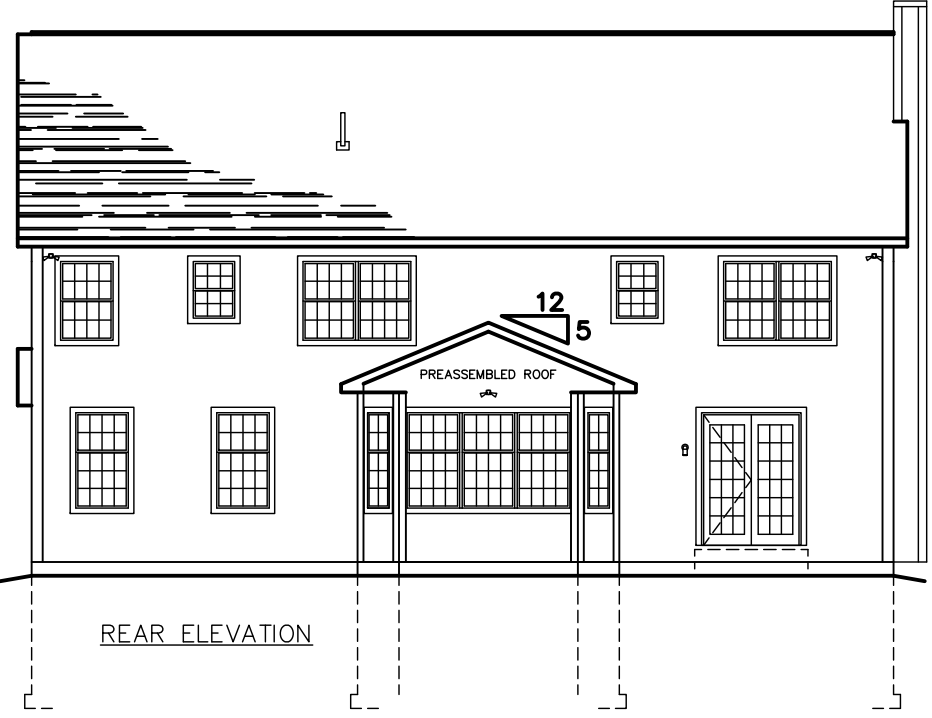
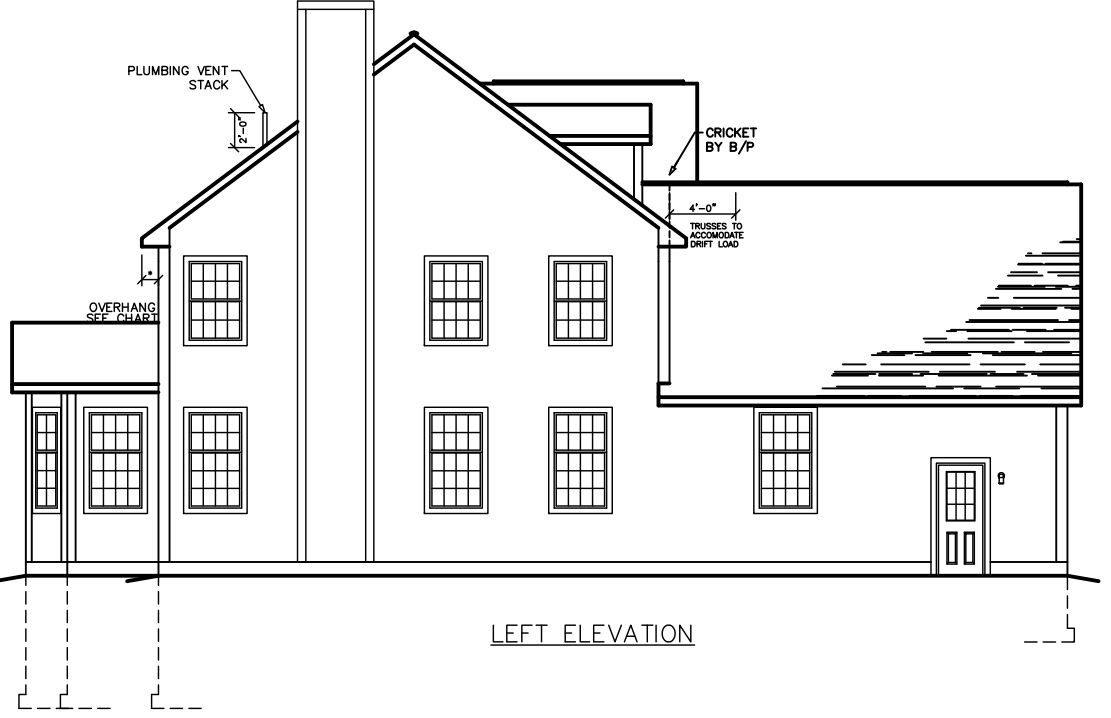
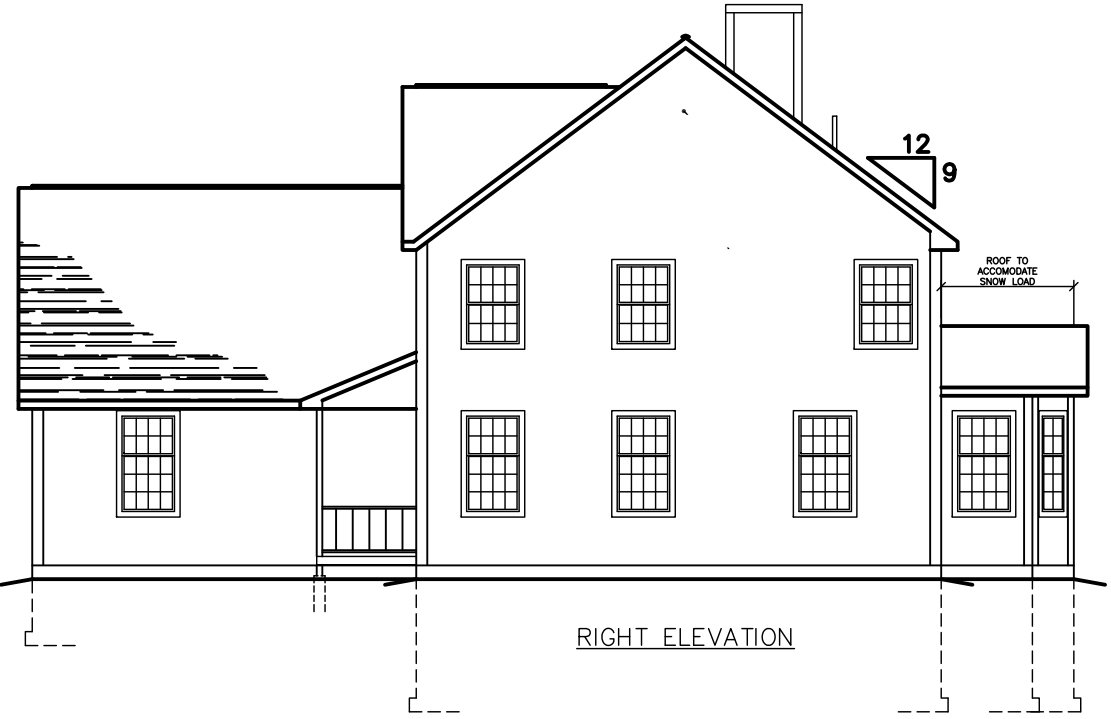



OVERHANG DIMENSION (*)			
ROOF PITCH	HOUSE WIDTH		
	24'-0"	26'-0"/30'-0"	27'-8"/31'-8"
5/12	16"	11"	16"
7/12	16"	11"	16"
9/12	12"	11"	12"
12/12	8 3/4"	8 3/4"	8 3/4"

NOTE:
WINDOW GRILLE PATTERNS SHOWN ARE FOR ANDERSEN WINDOWS.
GRILLE PATTERNS FOR OTHER MANUFACTURERS MAY BE DIFFERENT.

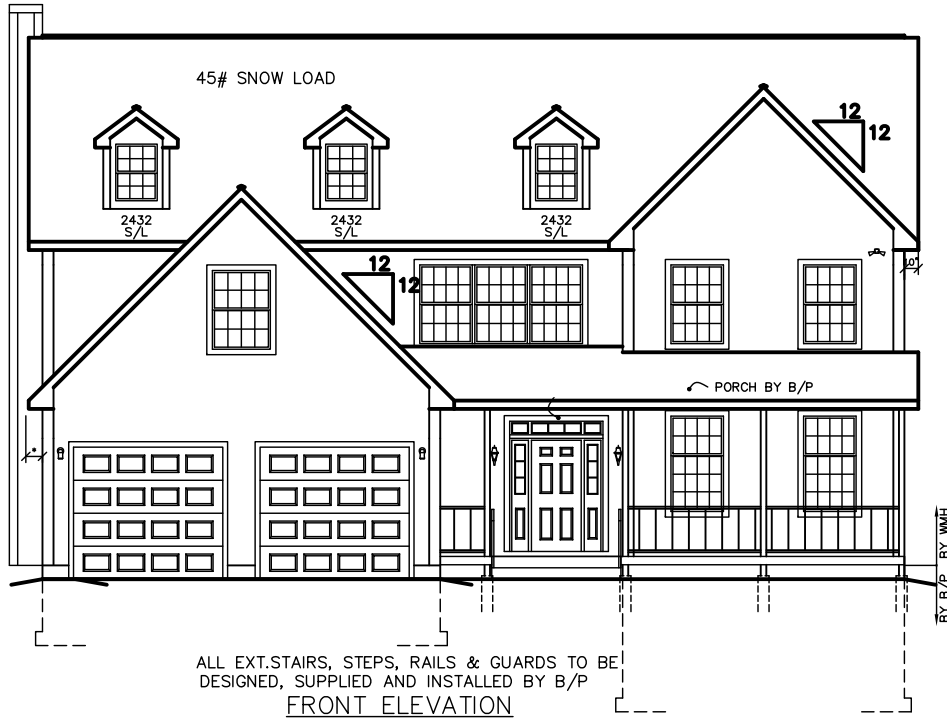

SEE STANDARD NOTES & DETAILS DWG #8

THIRD PARTY INSPECTION AGENCY		PE / RA	
SERIAL No.	04267	REVISION	DATE
PRODUCTION No.			10/21/04
			01/11/05
		CHECK	DATE
COLONIAL CTM-R ELEVATIONS		Westchester Modular Homes Inc 30 Reagans Mill Road, Wingdale, New York, 12594 Tel (914)832-9400 Fax (914)832-6698	
BUILDER: WMHCC 1995 ROUTE 22 BREWSTER, NY 10509	USE GROUP: SINGLE FAMILY	CONST. TYPE: 5B	DESIGNER: JJDW
			DATE: 09/24/04
			SCALE: 1/8" = 1'-0"
			PAGE: 1

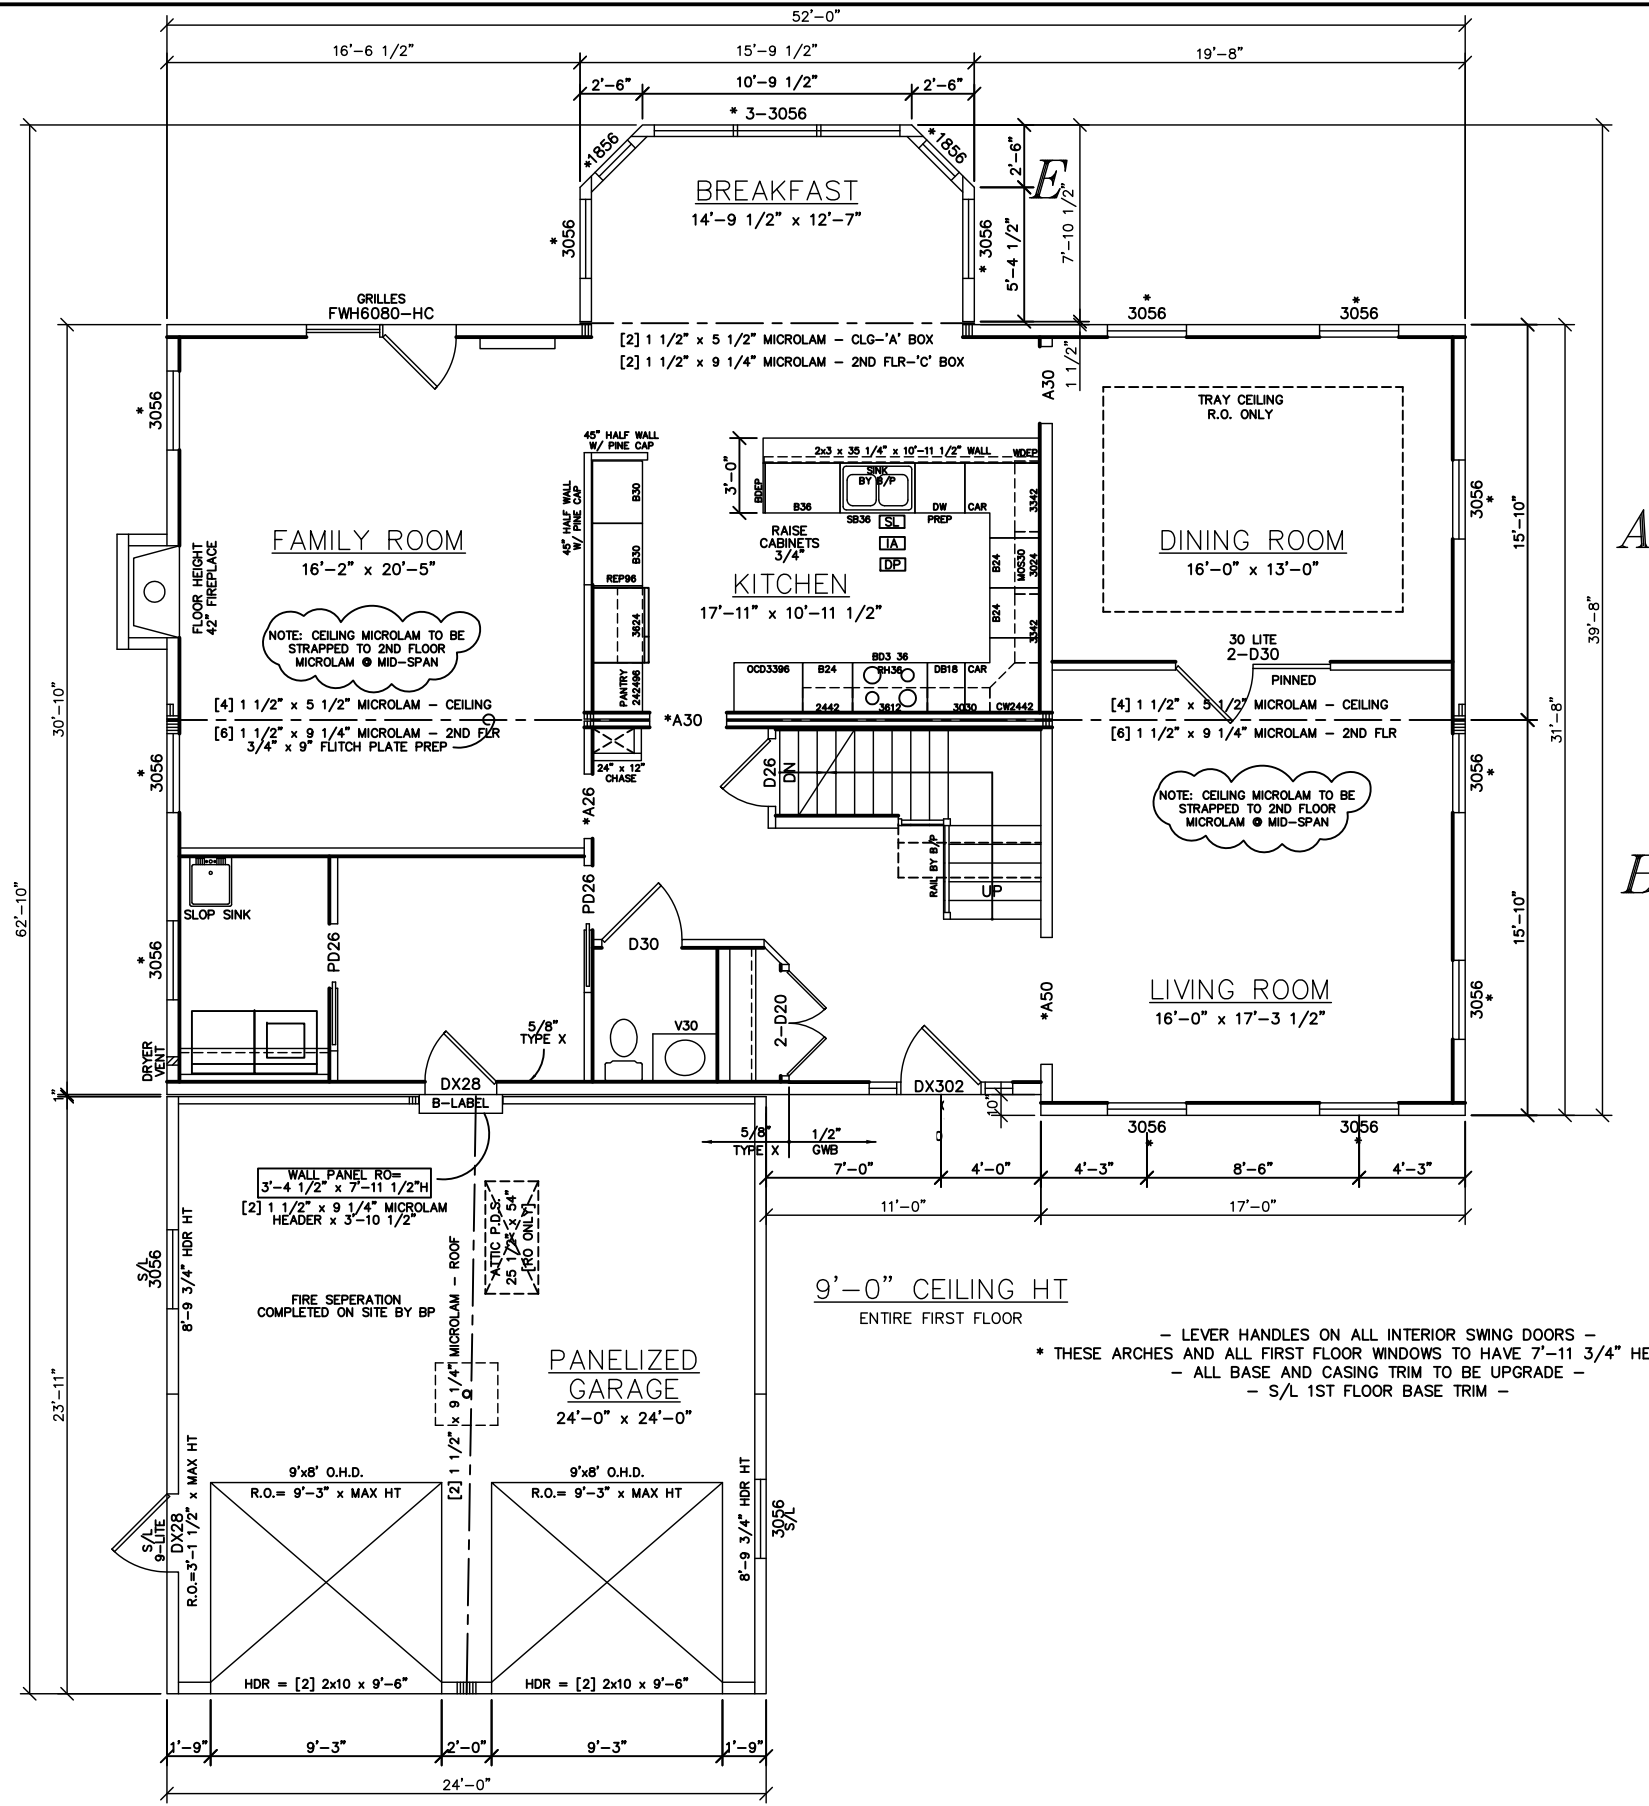


- LEVER HANDLES ON ALL INTERIOR SWING DOORS -
- * THESE ARCHES AND ALL FIRST FLOOR WINDOWS TO HAVE 7'-11 3/4" HEADERS *
- ALL BASE AND CASING TRIM TO BE UPGRADE -
- S/L 1ST FLOOR BASE TRIM -

LIGHT & VENTILATION SCHEDULE (SF)					
ROOM	AREA	LIGHT		VENT	
		REQUIRED	SUPPLIED	REQUIRED	SUPPLIED
KITCHEN	196	15.7	0.0	7.84	0.00
BREAKFAST	179	14.3	76.9	7.16	34.69
DINING ROOM	208	16.6	38.7	8.32	17.19
LIVING ROOM	275	22.0	51.6	11.00	22.92
FAMILY ROOM	330	26.4	47.7	13.20	27.57

SEE STANDARD NOTES & DETAILS DWG #8

SERIAL No. 04267 PRODUCTION No.		REVISION DATE 10/21/04 01/11/05		CHECK DATE	
USE GROUP: SINGLE FAMILY CONST. TYPE: 5B		BUILDER: WMHCC 1995 ROUTE 22 BREWSTER, NY 10509		DESIGNER: JDDW DATE: 09/24/04 SCALE: 3/16" = 1'-0" PAGE: 3A	
THIRD PARTY INSPECTION AGENCY PE / RA		COLONIAL CTM-R FIRST FLOOR PLAN Westchester Modular Homes Inc 30 Reagans Mill Road, Wingdale, New York, 12594 Tel (914)832-9400 Fax (914)832-6698			

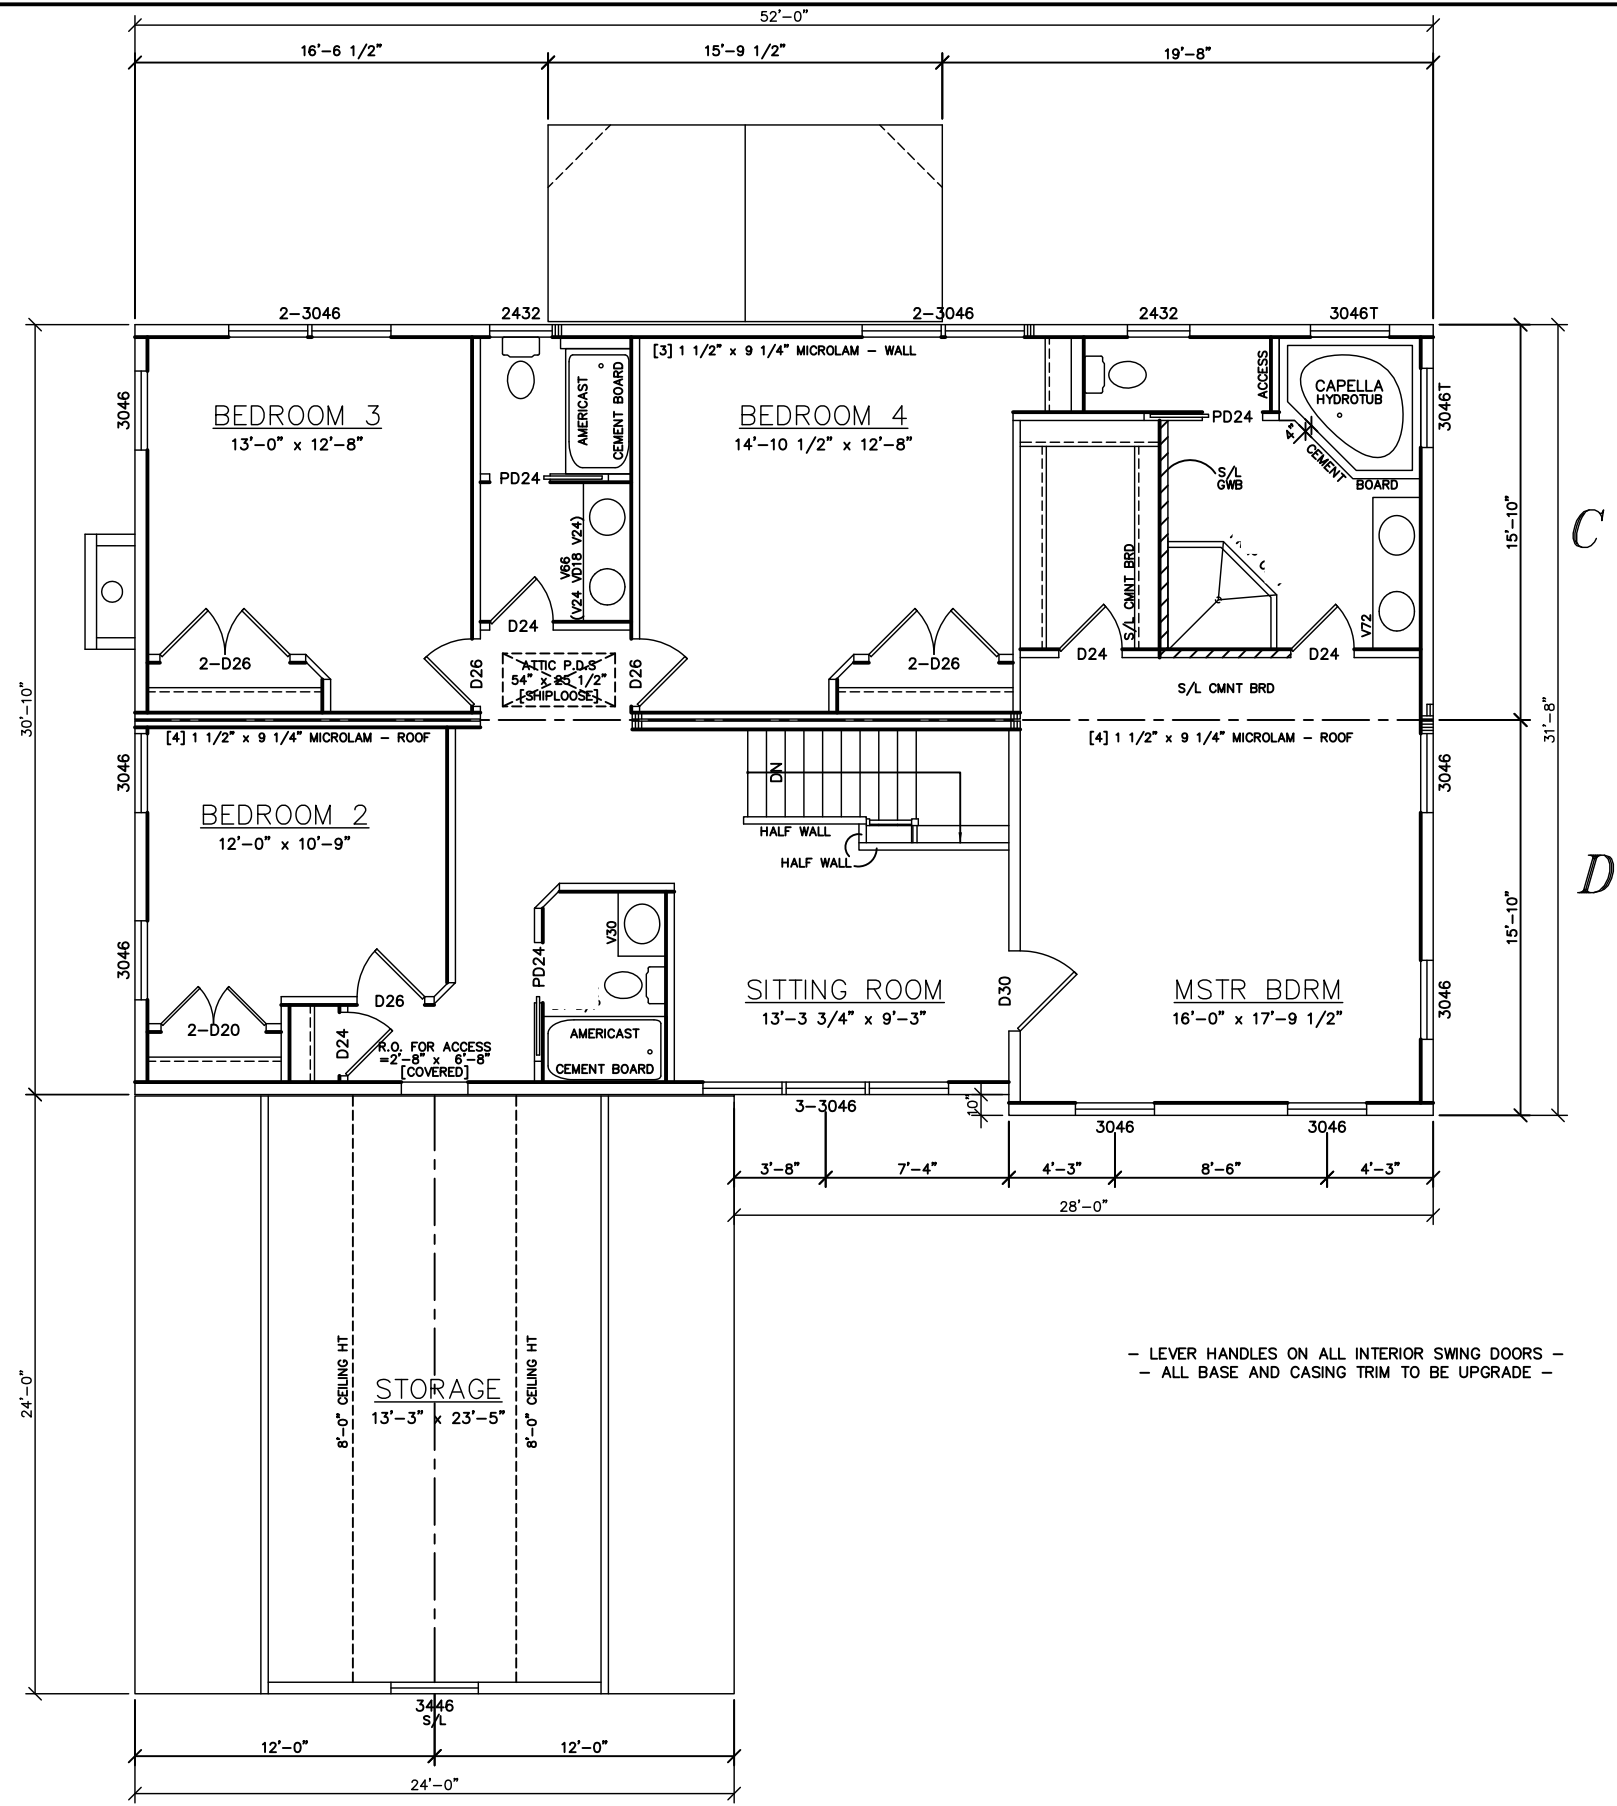

- LEVER HANDLES ON ALL INTERIOR SWING DOORS -
 - ALL BASE AND CASING TRIM TO BE UPGRADE -

LIGHT & VENTILATION SCHEDULE (SF)					
ROOM	AREA	LIGHT		VENT	
		REQUIRED	SUPPLIED	REQUIRED	SUPPLIED
MSTR BDRM	285	22.8	41.2	11.40	22.92
SITTING ROOM	133	10.6	30.9	5.32	17.19
BEDROOM 2	129	10.3	20.6	5.16	11.46
BEDROOM 3	165	13.2	30.9	6.60	17.19
BEDROOM 4	188	15.0	20.6	7.52	11.46

SEE STANDARD NOTES & DETAILS DWG #8

USE GROUP: SINGLE FAMILY	BUILDER: WMHCC 1995 ROUTE 22 BREWSTER, NY 10509	THIRD PARTY INSPECTION AGENCY:	PE / RA
CONSTR. TYPE: 5B	DESIGNER: JDM	SERIAL No.: 04267	
DATE: 09/24/04	SCALE: 3/16" = 1'-0"	PRODUCTION No.:	
PAGE: 3B	COLONIAL CTM-R SECOND FLOOR PLAN	REVISION	DATE
	Westchester Modular Homes Inc 30 Reagans Mill Road, Wingdale, New York, 12594 Tel (914)832-9400 Fax (914)832-6698	CHECK	DATE